


DO NOT SCALE

THE CONTRACTOR IS TO CHECK AND VERIFY ALL BUILDING AND SITE DIMENSIONS, LEVELS AND SEWER INVERT LEVELS AT CONNECTION POINTS BEFORE WORK STARTS

THIS DRAWING IS TO BE READ AND CHECKED IN CONNECTION WITH ENGINEERS AND OTHER SPECIALIST DRAWINGS

THIS DRAWING AND THE WORKS DEPICTED ARE THE COPYRIGHT OF THIS FIRM AND MAY NOT BE REPRODUCED EXCEPT BY WRITTEN PERMISSION

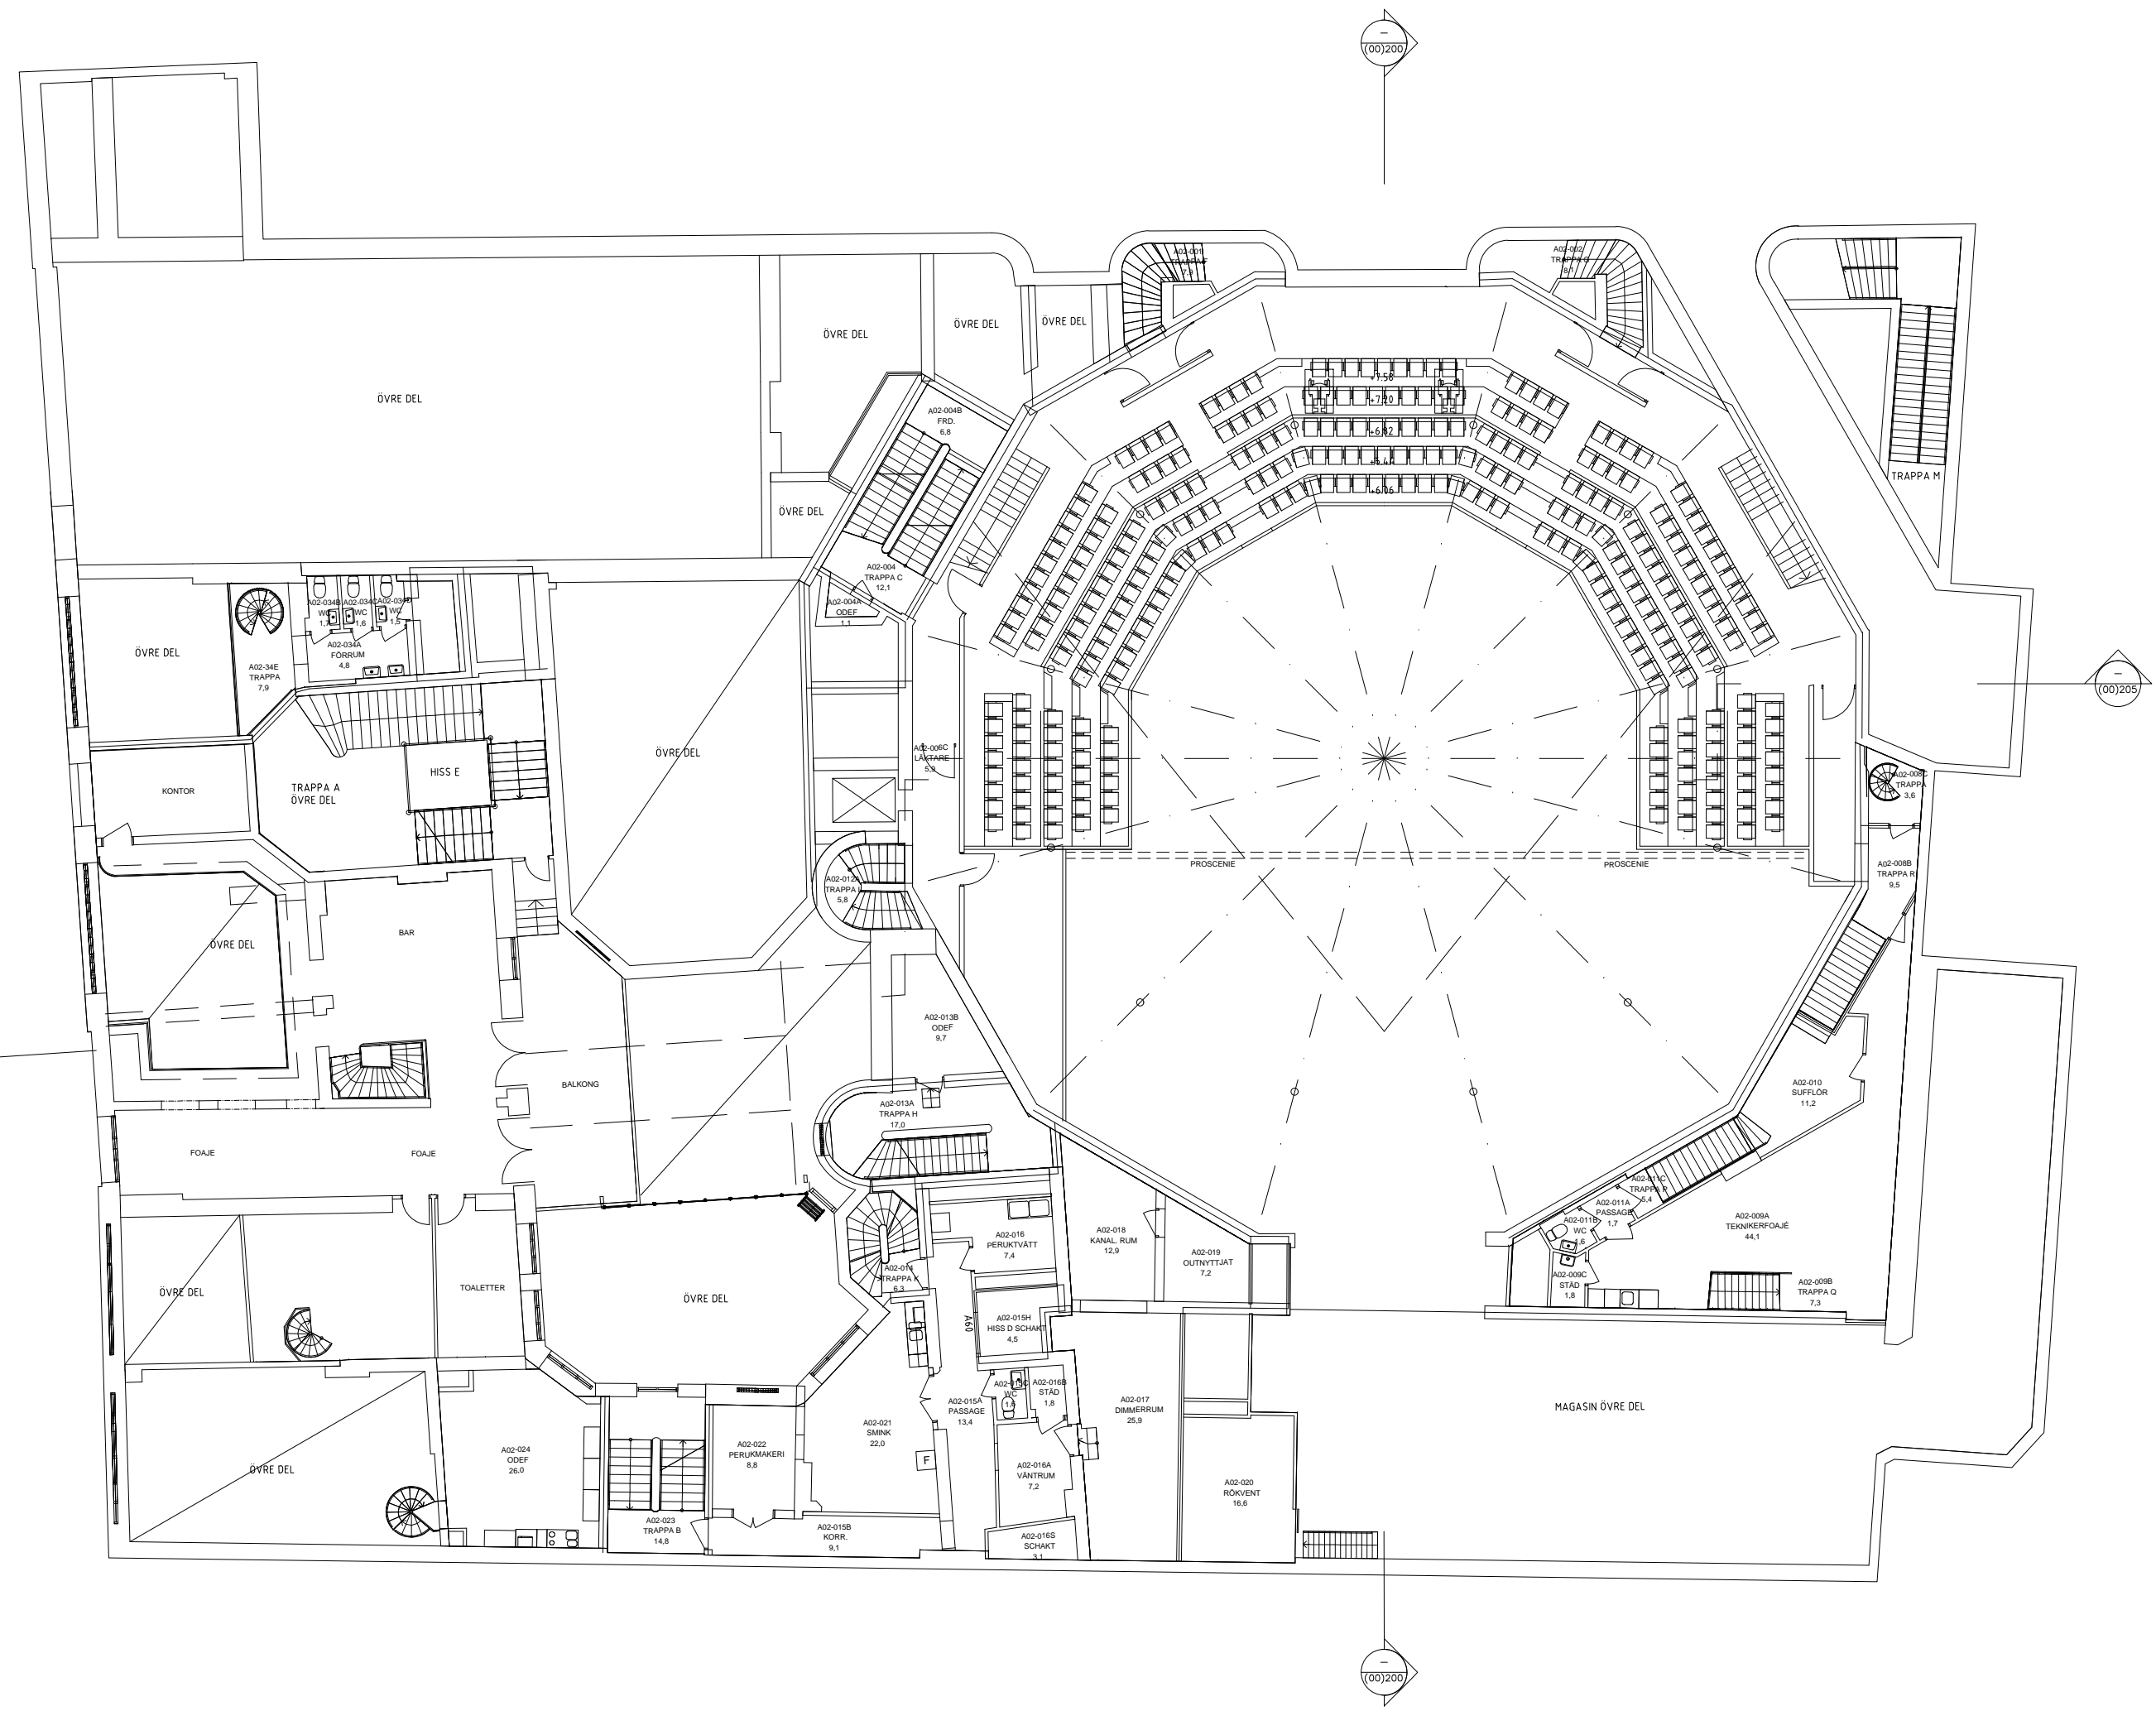

— 14.01.19 DRAFT ISSUE TO CONSULTANT TEAM	
REV	DESCRIPTION
HaworthTompkins <small>35 Grosvenor Place, London, NW1S 1B +44 (0) 20 7300 2225 www.haworthtompkins.com</small>	
JOB	1714: MALMO STADSTEATER
DRG	PROPOSED FIRST FLOOR PLAN
DRG No	REV
1714-L(00)102	—
SCALE 1:200 @ A3	DATE DEC 18
DRAWN BY ML / RW	INSPECTED BY RW
DRAWING STATUS: FOR INFORMATION	