


DO NOT SCALE

THE CONTRACTOR IS TO CHECK AND VERIFY ALL BUILDING AND SITE DIMENSIONS, LEVELS AND SEWER INVERT LEVELS AT CONNECTION POINTS BEFORE WORK STARTS

THIS DRAWING IS TO BE READ AND CHECKED IN CONJUNCTION WITH ENGINEERS AND OTHER SPECIALIST DRAWINGS

THE DRAWING AND THE WORKS DEPICTED ARE THE COPYRIGHT OF THIS FIRM AND MAY NOT BE REPRODUCED EXCEPT BY WRITTEN PERMISSION

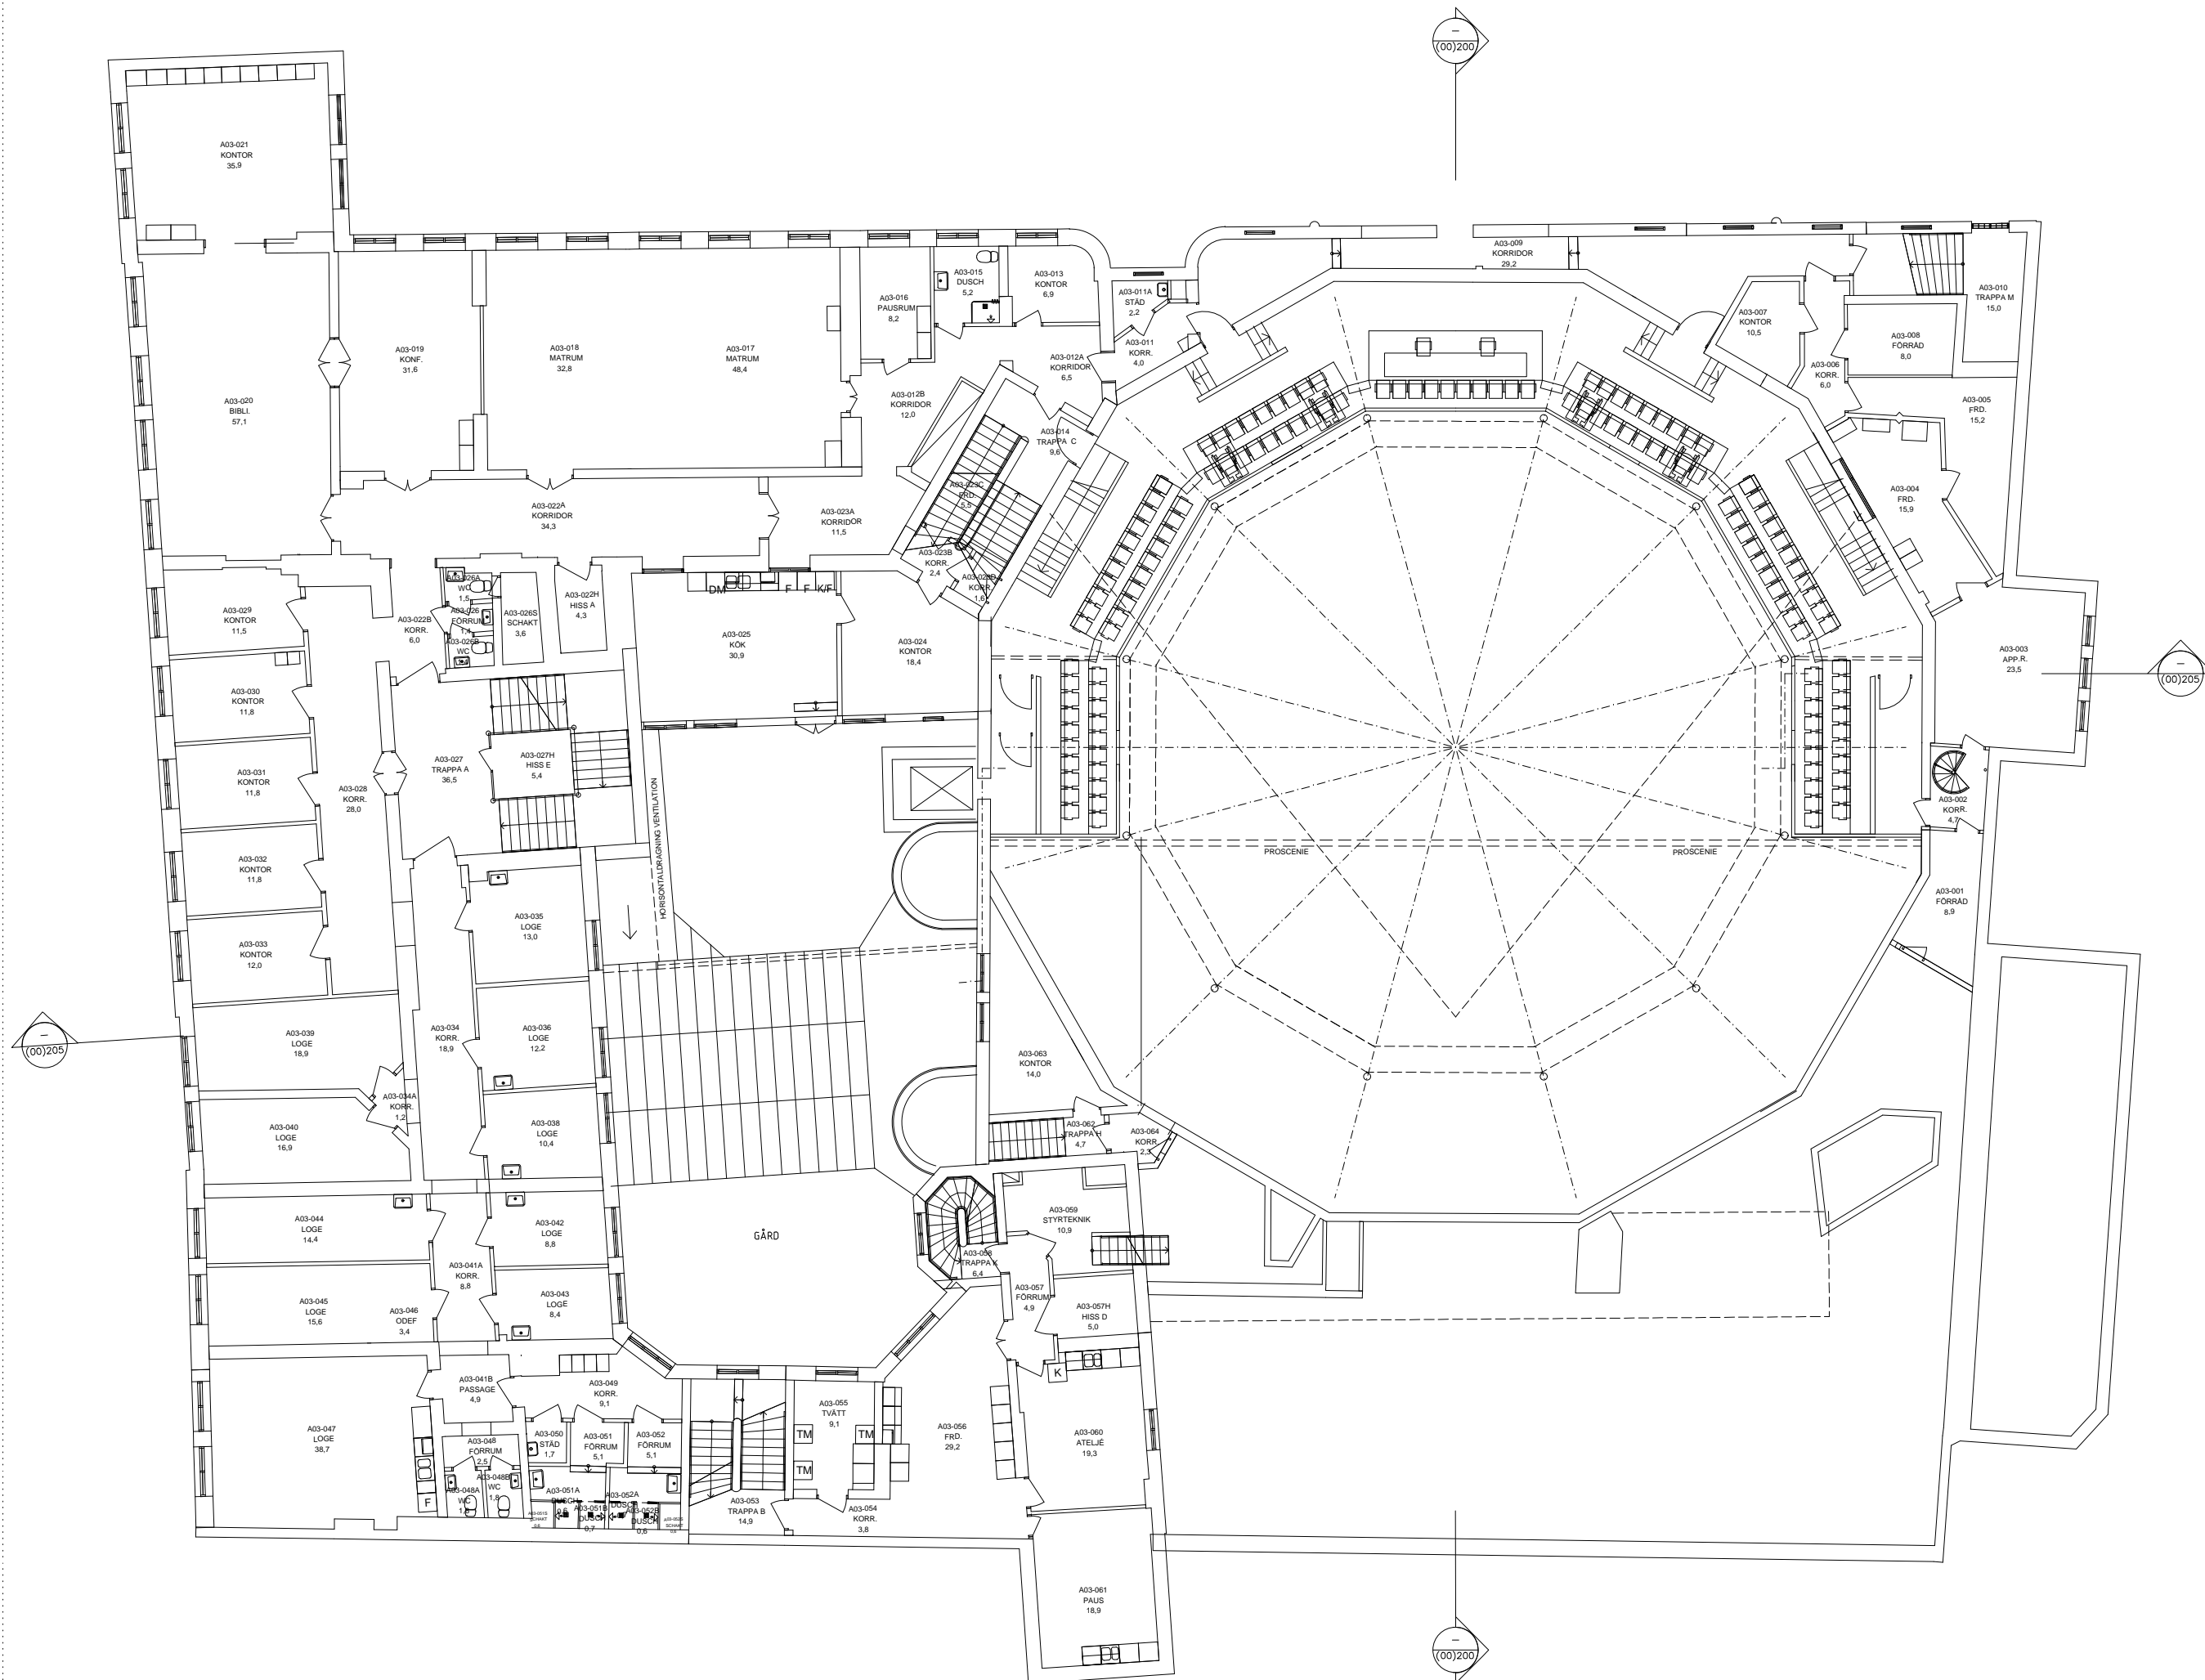

REV	DATE	DESCRIPTION
-	14.01.19	DRAFT ISSUE TO CONSULTANT TEAM

**HaworthTompkins**  
35 Grosvenor Place, London, NW1S 1LR  
+44 (0) 20 7290 3225 | www.haworthtompkins.com

JOB 1714: MALMO STADSTEATER

ORG  
PROPOSED  
SECOND FLOOR PLAN

ORG No 1714-L(00)103 REV -

SCALE 1:200 @ A3 DATE DEC 18

DRAWN BY ML / RW INSPECTED BY RW

DRAWING STATUS FOR INFORMATION